



WATER TANK FOR BUILDING CAP=36,900 ltrs. (Revised Plan) Dated: 29/06/2018
 License issued under No. A/138-14 Dated: 07/11/2013
 Subject to the conditions stipulated therein.

CHIEF OFFICER, MARGAO MUNICIPAL COUNCIL

Municipal Engineer Margao Municipal Council

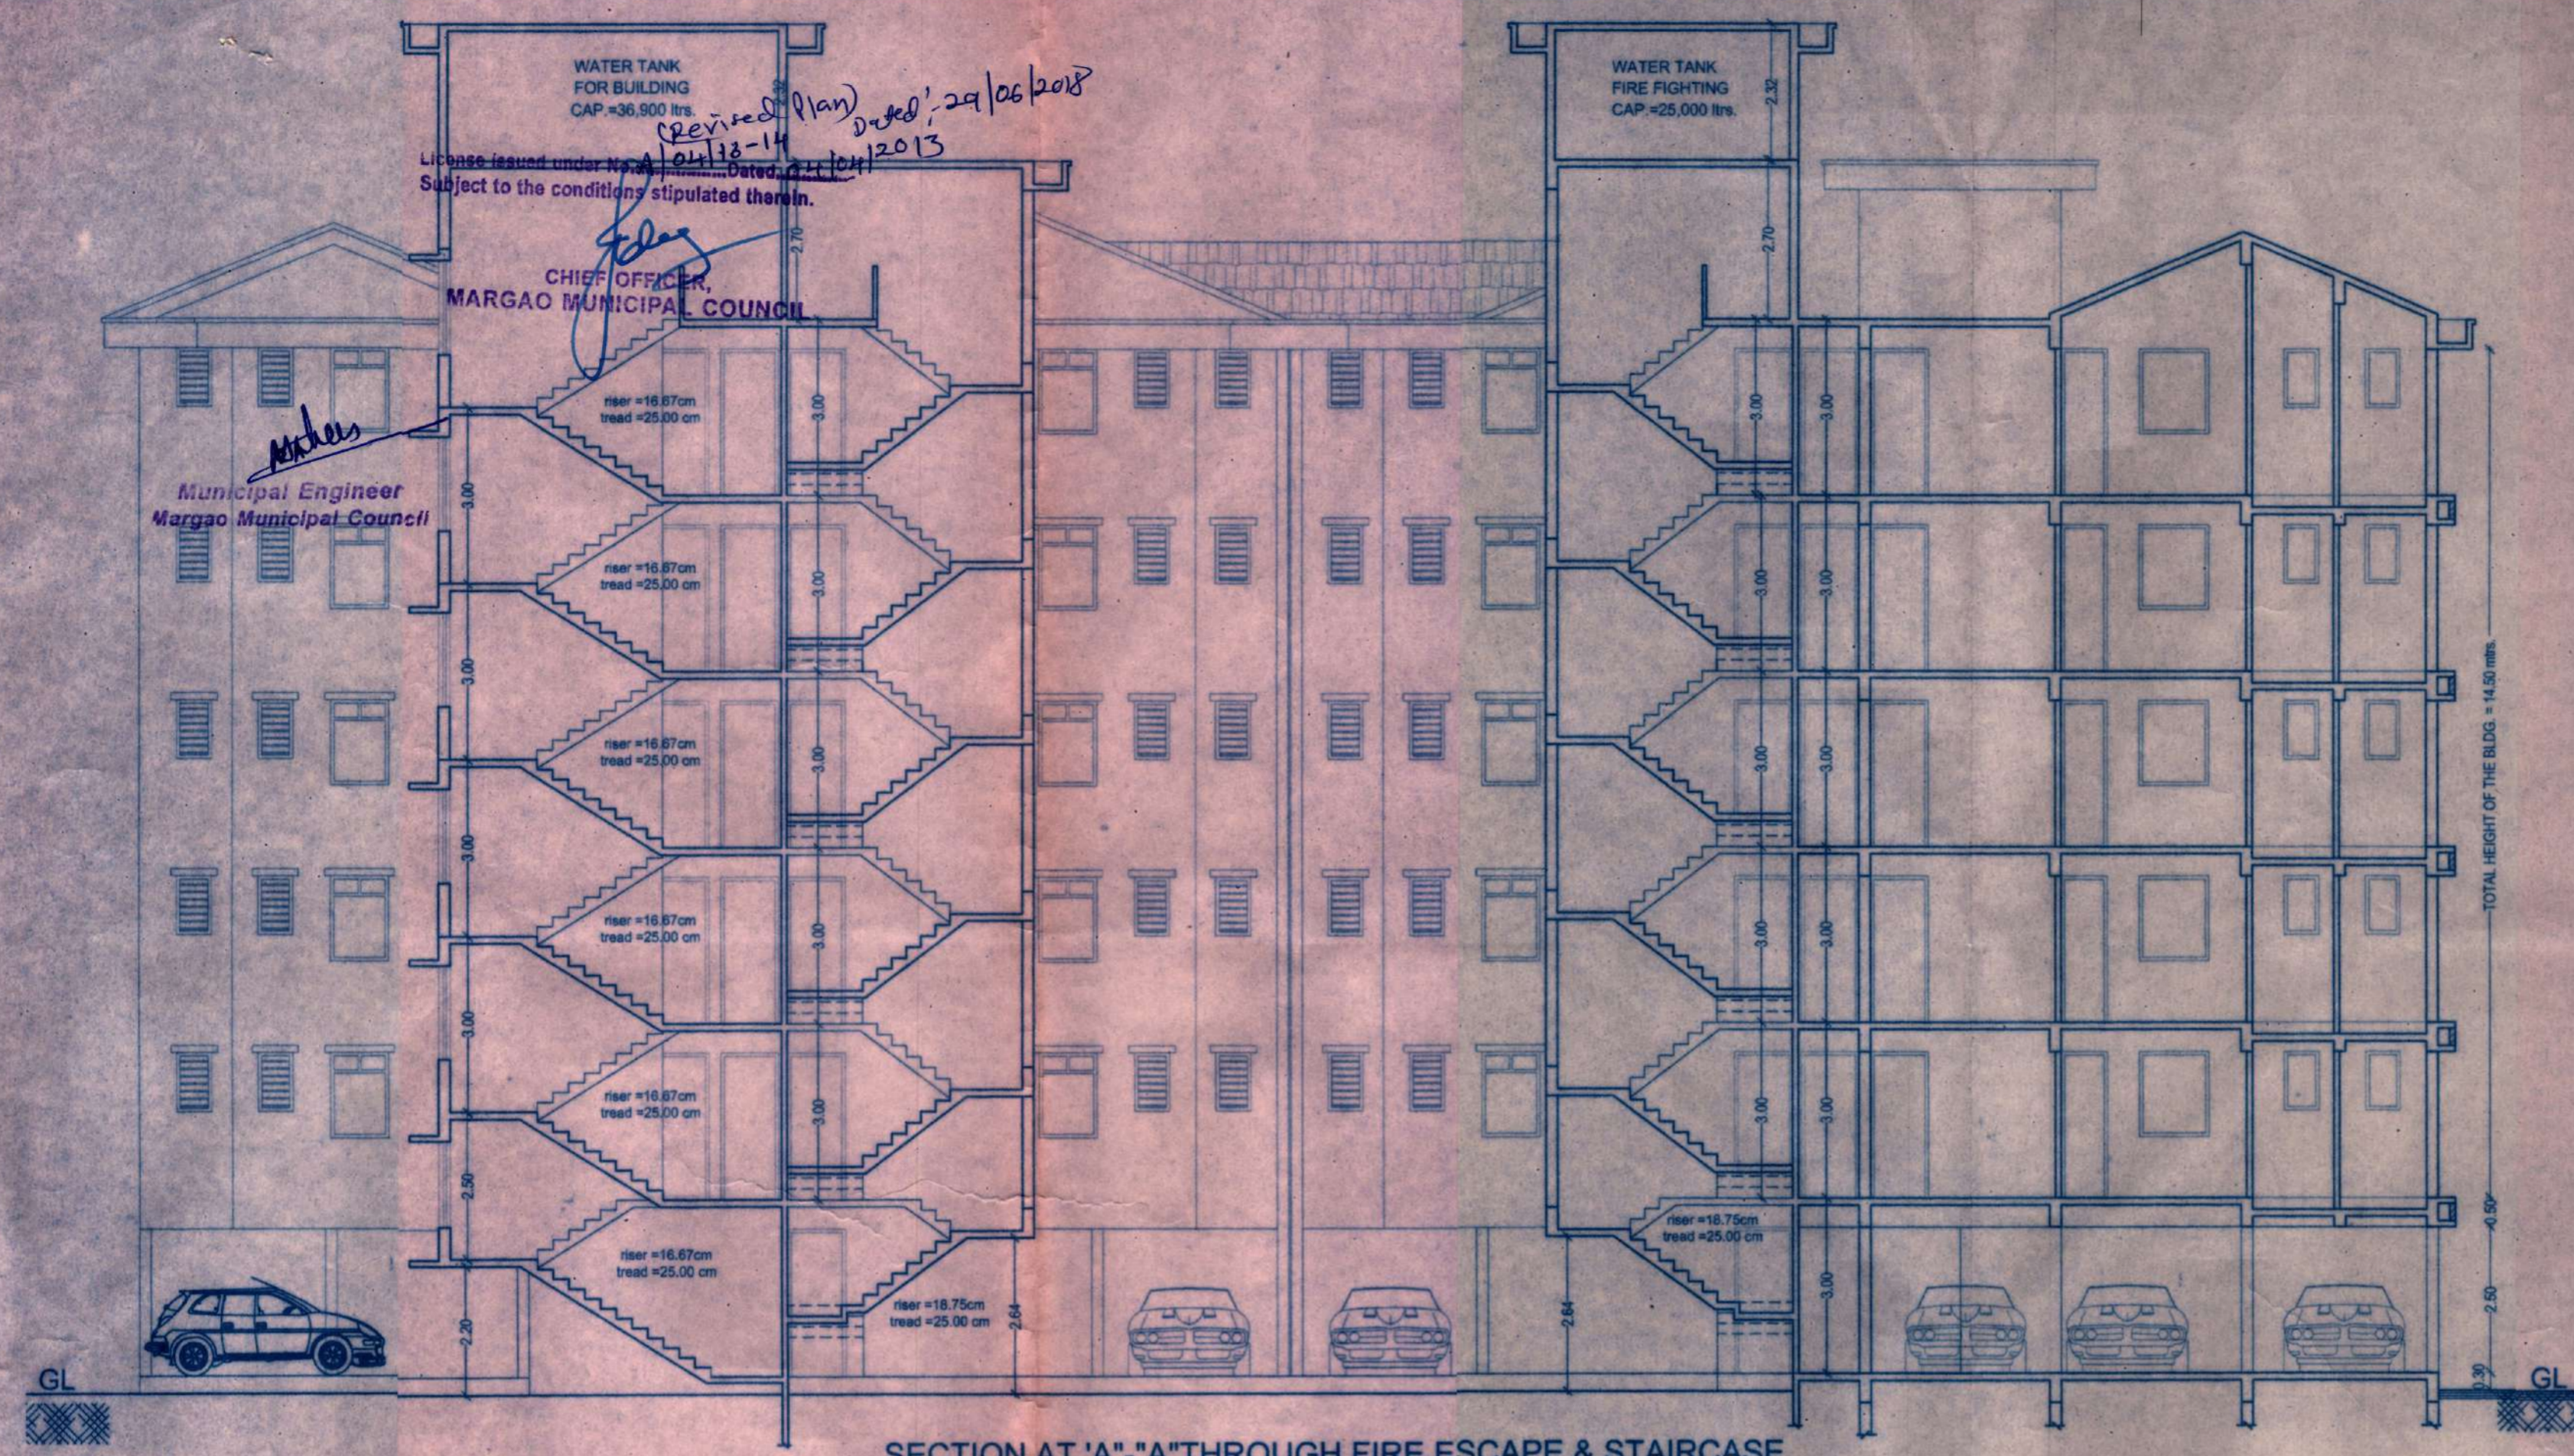

SECTION AT 'A'- 'A' THROUGH FIRE ESCAPE & STAIRCASE

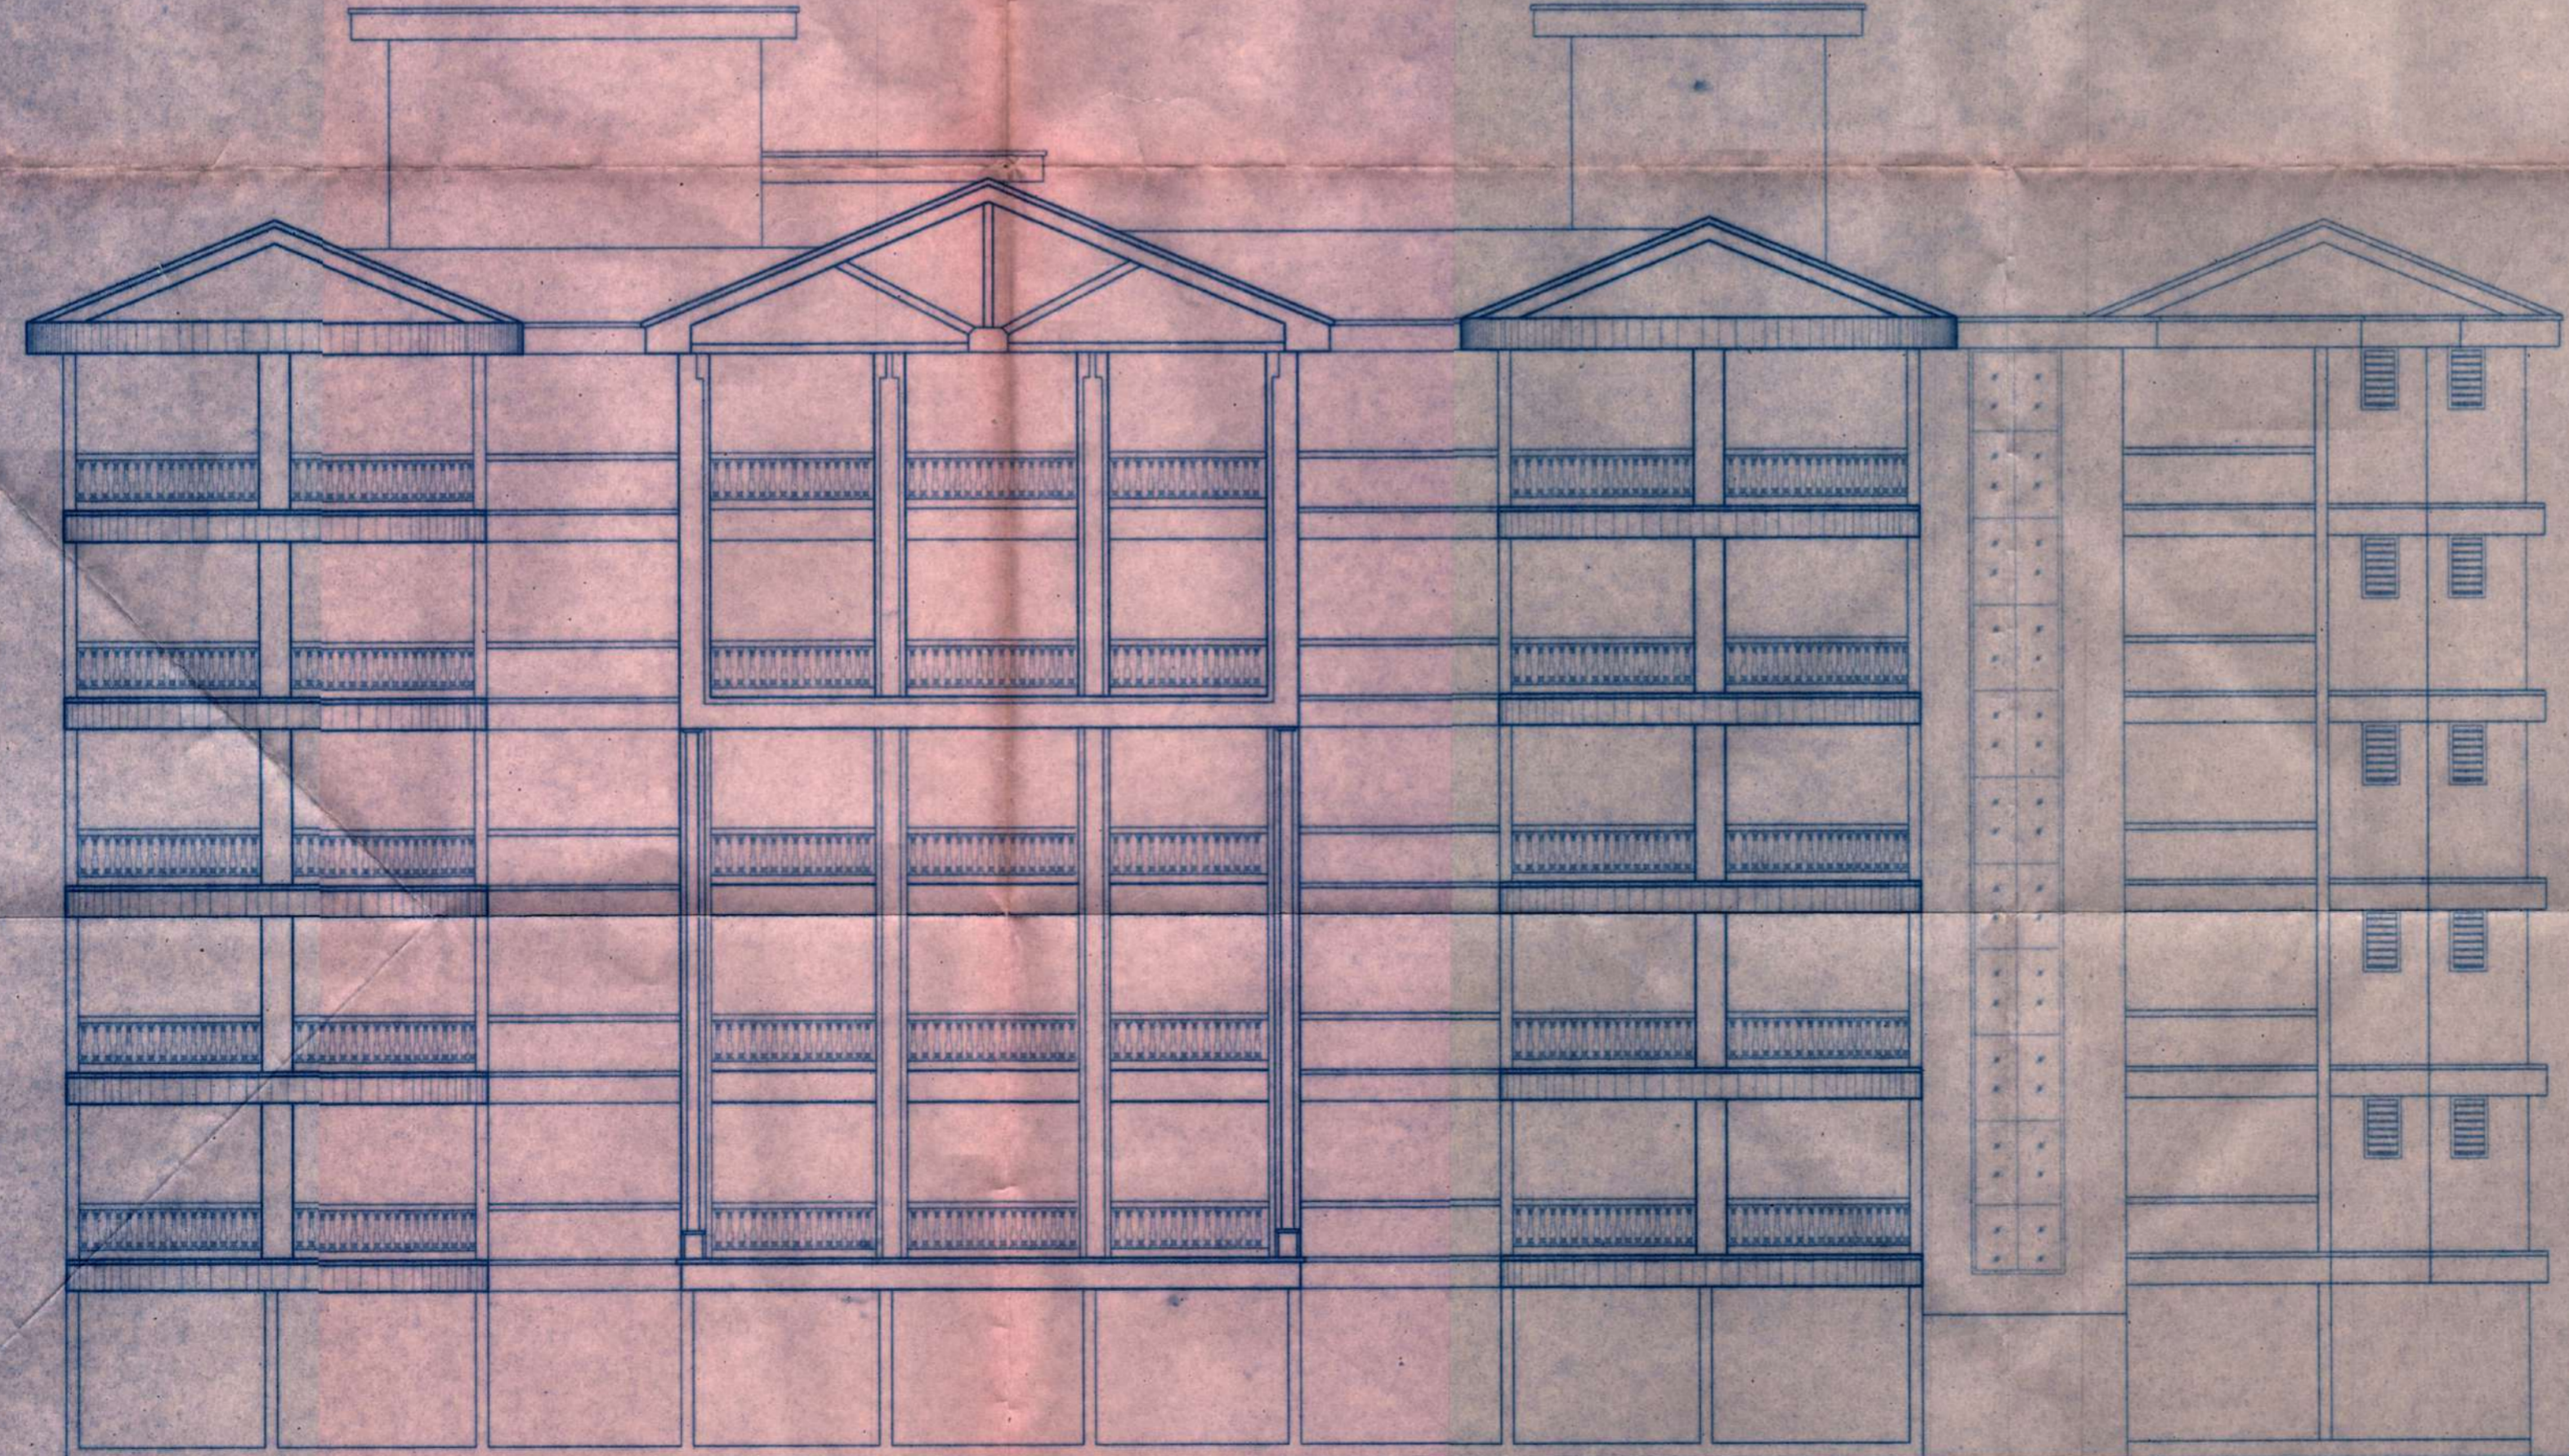

FRONT ELEVATION

Development Permission Granted Subject to Conditions Vide Order No. SGPDA/PI...S.H.S./124/16-17 Dated: 25/11/16
 Member Secretary

HEALTH OFFICER URBAN HEALTH CENTRE MARGAO

'B' BUILDING

ENGINEER'S SIGNATURE :
 UDAY SAWANT
 B.E.(CIVIL)
 Reg. No. ER/0022/2010

OWNER'S SIGNATURE :
 [Signature]

| | |
|--|--|
| OWNER: MR. MENINO DE SILVA & OTHERS. | |
| PROJECT : ADDITION OF 'B' BUILDING, SWIMMING POOL AND REVISION OF SITE PLAN AT AQUEM, MARGAO. | |
| JOB NO-795 | P.T. SHEET NO.225/CH. NO.1(PART)5 TO13 P.T. S. NO.226/CH.NO.46 TO 51 & P.T. S. NO.225/CH.NO.126,127 & 128 |
| DATE-28-10-2013 | DRG. NO-504-B/01 |
| DEALT-SNEHA | SCALE-1:100,1:500. |
| SAWANT & ASSOCIATES ARCHITECTS, ENGINEERS INTERIOR DESIGNERS SAFANA ARCADE, 1ST FLOOR HALBHAT, BDA. PHONE NO.03: 2736692 | |